



THE INFORMATION AND ILLUSTRATIONS CONTAINED IN THIS DRAWING ARE THE PROPERTY OF FOLIUMCEI. ANY UNAUTHORIZED REPRODUCTION IN WHOLE OR IN PART IS STRICTLY PROHIBITED.

| REVISIONS | | | |
|-----------|-----------------|----------|----------|
| REV | DESCRIPTION | DATE | APPROVED |
| A | INITIAL RELEASE | 3/1/2007 | GS |

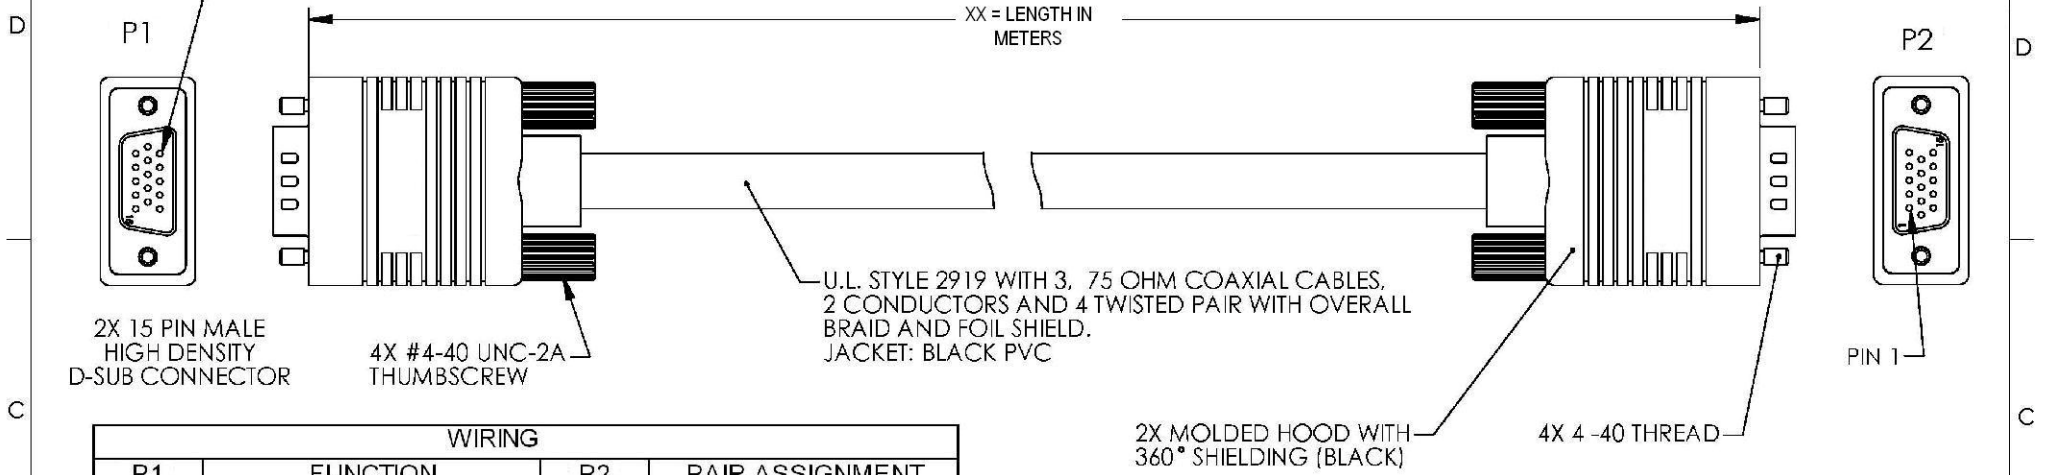

| WIRING | | | |
|--------|------------------------------|-------|----------------------|
| P1 | FUNCTION | P2 | PAIR ASSIGNMENT |
| 1 | RED SIGNAL | 1 | |
| 2 | GREEN SIGNAL | 2 | |
| 3 | BLUE SIGNAL | 3 | |
| 4 | ID BIT 2 | 4 | PAIR 1 |
| 5 | GROUND | 5 | |
| 6 | RED SHIELD | 6 | |
| 7 | GREEN SHIELD | 7 | |
| 8 | BLUE SHIELD | 8 | |
| 9 | DDC +5V | 9 | |
| 10 | SYNC RETURN | 10 | |
| 11 | ID BIT 0 | 11 | PAIR 2 |
| 12 | BIDIRECTIONAL DATA | 12 | |
| 13 | HORIZONTAL SYNC | 13 | |
| 14 | VERTICAL SYNC | 14 | PAIR 3 (WITH PIN 10) |
| 15 | ID BIT 3, DATA CLOCK | 15 | PAIR 4 (WITH PIN 10) |
| SHELL | BRAIDED SHIELD OR DRAIN WIRE | SHELL | |

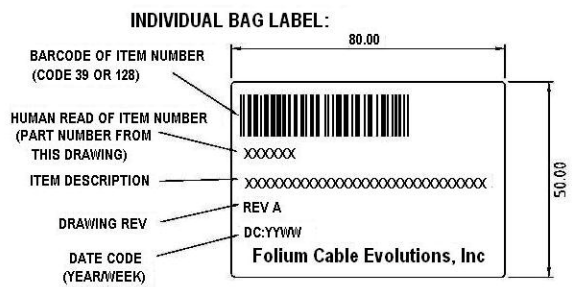

NOTES:
 CABLE ASSEMBLIES SHALL BE TESTED FOR CONTINUITY
 CABLE ASSEMBLIES SHALL BE INDIVIDUALLY PACKAGED IN A POLYBAG



UNLESS OTHERWISE SPECIFIED, DIMENSIONS ARE IN INCHES. TOLERANCES ARE:
 .X ±.1
 .XX ±.05
 .XXX ±.005
 CABLE LENGTH TOLERANCE
 <300" ±5% >300" ±2%

| APPROVALS | DATE |
|-------------------|------------|
| DRAWN BY SC | 03/01/2007 |
| CHECKED BY MH | 03/01/2007 |
| APPROVED BY GS | 03/01/2007 |



| | | |
|--|---|------------------|
| ITEM DESCRIPTION SVGA CABLE ASSY, HD15 MALE / MALE, MOLDED, BLACK | | |
| SIZE A | ITEM NUMBER 1066XX where "XX" = Length in Meters | REV. A |
| SCALE: NONE CAD FILE: AUTHORIZED ACCESS ONLY | | SHEET 1 OF 1 |